

AMENDMENT OF SOLICITATION/MODIFICATION OF CONTRACT				1. CONTRACT ID CODE		PAGE 1 OF 5 PAGES	
2. AMENDMENT/MODIFICATION NO. AMENDMENT NO. 0001		3. EFFECTIVE DATE 07/17/17		4. REQUISITION/PURCHASE REQ. NO.		5. PROJECT NO. (If applicable) 17-0052	
6. ISSUED BY NAVFAC Mid-Atlantic Resident Officer in Charge of Construction 1005 Michael Road Camp Lejeune, NC 28547-2521		CODE N40085		7. ADMINISTERED BY (If other than Item 6) See Item 6		CODE	
8. NAME AND ADDRESS OF CONTRACTOR (No., street, county, State and ZIP Code)				(X)		9A. AMENDMENT OF SOLICITATION NO. N40085-17-R-3068	
				X		9B. DATED (SEE ITEM 11) 06/30/17	
						10A. MODIFICATION OF CONTRACT/ORDER NO.	
						10B. DATED (SEE ITEM 11)	
CODE		FACILITY CODE					

11. THIS ITEM ONLY APPLIES TO AMENDMENTS OF SOLICITATIONS

The above numbered solicitation is amended as set forth in Item 14. The hour and date specified for receipt of Offers is extended, is not extended.
 Offers must acknowledge receipt of this amendment prior to the hour and date specified in the solicitation or as amended, by one of the following methods:
 (a) By completing items 8 and 15, and returning _____ copies of the amendment; (b) By acknowledging receipt of this amendment on each copy of the offer submitted;
 or (c) By separate letter or telegram which includes a reference to the solicitation and amendment numbers. FAILURE OF YOUR ACKNOWLEDGMENT TO BE RECEIVED AT THE PLACE DESIGNATED FOR THE RECEIPT OF OFFERS PRIOR TO THE HOUR AND DATE SPECIFIED MAY RESULT IN REJECTION OF YOUR OFFER. If by virtue of this amendment your desire to change an offer already submitted, such change may be made by telegram or letter, provided each telegram or letter makes reference to the solicitation and this amendment, and is received prior to the opening hour and date specified.

12. ACCOUNTING AND APPROPRIATION DATA (If required)

**13. THIS ITEM ONLY APPLIES TO MODIFICATION OF CONTRACTS/ORDERS.
IT MODIFIES THE CONTRACT/ORDER NO. AS DESCRIBED IN ITEM 14.**

CHECK ONE	A. THIS CHANGE ORDER IS ISSUED PURSUANT TO: (Specify authority) THE CHANGES SET FORTH IN ITEM 14 ARE MADE IN THE CONTRACT ORDER NO. IN ITEM 10A.
	B. THE ABOVE NUMBERED CONTRACT/ORDER IS MODIFIED TO REFLECT THE ADMINISTRATIVE CHANGES (such as changes in paying office, appropriation date, etc.) SET FORTH IN ITEM 14, PURSUANT TO THE AUTHORITY OF FAR 43.103(b).
	C. THIS SUPPLEMENTAL AGREEMENT IS ENTERED INTO PURSUANT TO AUTHORITY OF:
	D. OTHER (Specify type of modification and authority)

E. IMPORTANT: Contractor is not, is required to sign this document and return _____ copies to the issuing office.

14. DESCRIPTION OF AMENDMENT/MODIFICATION (Organized by UCF section headings, including solicitation/contract subject matter where feasible.)

17-0052 Tank Trail and Culvert Repairs Basewide

The time and date for receipt of proposals remains unchanged.

This amendment should be acknowledged when your proposal is submitted. Failure to acknowledge the amendment may constitute grounds for rejection of a proposal.

SEE CONTINUATION PAGE

Except as provided herein, all terms and conditions of the document referenced in Item 9A or 10A, as heretofore changed, remains unchanged and in full force and effect.

15A. NAME AND TITLE OF SIGNER (Type or print)		16A. NAME AND TITLE OF CONTRACTING OFFICER (Type or print)	
15B. CONTRACTOR/OFFEROR (Signature of person authorized to sign)		16B. UNITED STATES OF AMERICA (Signature of Contracting Officer)	
15C. DATE SIGNED		16C. DATE SIGNED	

CONTINUATION PAGE

1. Incorporate attached Drawings C-10 and C-11 into the contract to include an additional culvert washout on Verona Loop Road.
2. Delete previously issued Pricing Sheet and incorporate attached Revised Pricing Sheet.

REVISED PRICING SHEET

Under the line items furnished, the offers shall state prices for each Exhibit Line Item Number (ELIN) given hereinafter:

ELIN 0001

Price includes completing all work associated with Repair Culvert Pipes, Holcomb Blvd/Sawmill Road Site in accordance with the provided drawings and specifications, but excluding work described in ELINs 0002, 0003, 0004, and 0005. The price for this line item should include all applicable costs, overhead and profit for this work.

\$ _____

ELIN 0002

Price includes completing all work associated with Repair Onslow Beach Road Culvert Pipes in accordance with the provided drawings and specifications, but excluding work described in ELINs 0001, 0003, 0004, and 0005. The price for this line item should include all applicable costs, overhead and profit for this work.

\$ _____

ELIN 0003

Price includes completing all work associated with Horn Road Tank Crossing in accordance with the provided drawings and specifications, but excluding work described in ELINs 0001, 0002, 0004, and 0005. The price for this line item should include all applicable costs, overhead and profit for this work.

\$ _____

ELIN 0004

Price includes completing all work associated with Repair Lewis Creek Road Culvert Pipes in accordance with the provided drawings and specifications, but excluding work described in ELINs 0001, 0002, 0003, and 0005. The price for this line item should include all applicable costs, overhead and profit for this work.

\$ _____

ELIN 0005

Price includes completing all work associated with Culvert Washout on Verona Loop Road in accordance with the provided drawings and specifications, but excluding work described in ELINs 0001, 0002, 0003, and 0004. The price for this line item should include all applicable costs, overhead and profit for this work.


\$ _____

TOTAL ELINs 0001 – 0005:


\$ _____

Notes

- A. Offers must be submitted on all line items. Failure to propose on all line items may result in the offer being rejected as non-responsive.
- B. ELINs shall include all markups (overhead, labor burden, and profit).
- C. Award will be made on the total sum of ELINs 0001, 0002, 0003, 0004, and ELIN 0005.

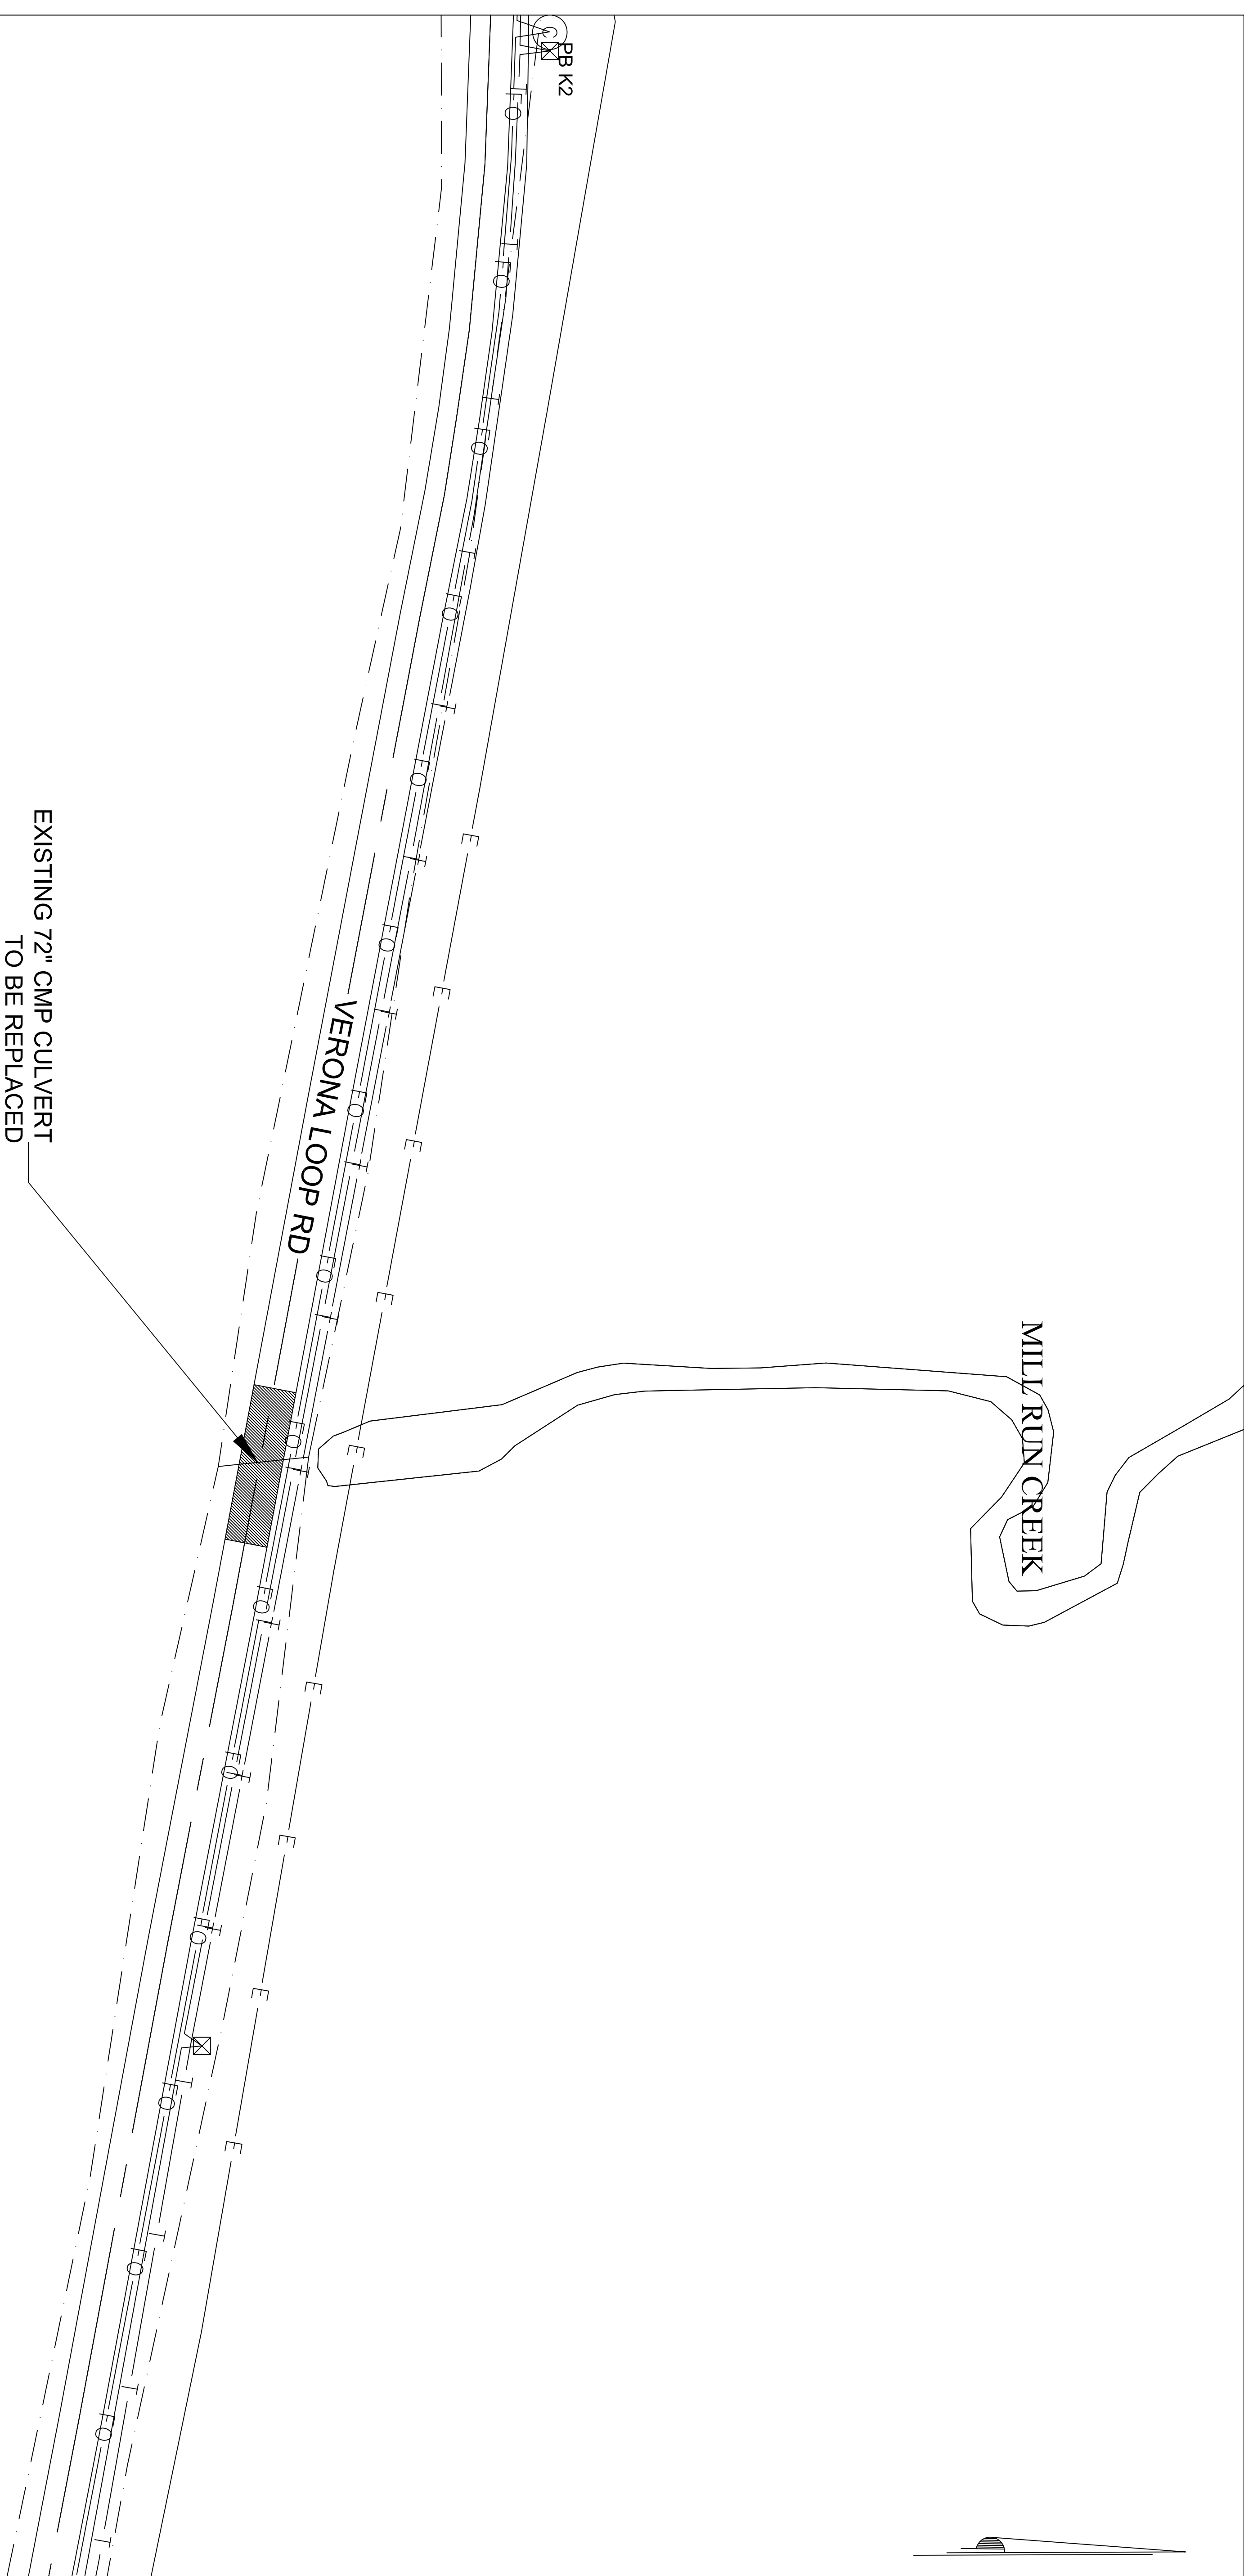

VERONA LOOP RD SITE PLAN

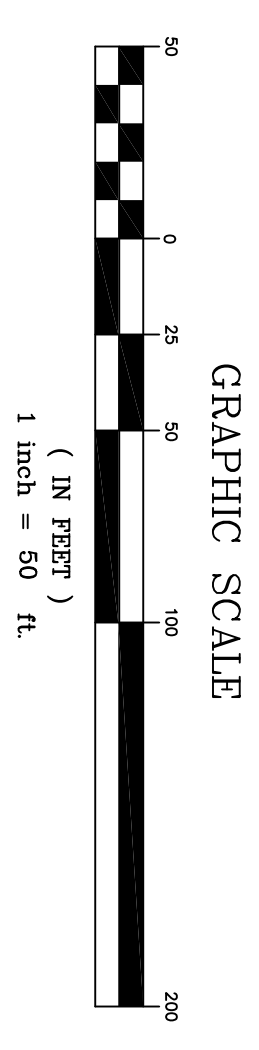

GENERAL NOTES:

1. CONTRACTOR SHALL LOCATE ALL UNDERGROUND UTILITIES PRIOR TO GROUND DEMOLITION ACTIVITIES.
2. CONTRACTOR SHALL FIELD VERIFY ALL MEASUREMENTS.
3. PRESERVE AND PROTECT ALL EXISTING UTILITIES. CONTRACTOR IS RESPONSIBLE FOR ANY DAMAGE TO UTILITIES.
4. CONTRACTOR SHALL COORDINATE ALL CONSTRUCTION ACTIVITIES WITH ROICC. CONTRACTOR MUST MINIMIZE SEDIMENT MIGRATION DOWNSTREAM TO THE MAXIMUM EXTENT PRACTICAL.
5. ALL EXCAVATIONS SHALL HAVE SLOPES NO STEEPER THAN 3:1.
6. UNDERGROUND UTILITIES SHALL BE PROTECTED AND TRAFFIC CONTROL NECESSARY TO SAFE CONSTRUCTION ACTIVITIES AND TRAFFIC CONTROL SHALL BE IN ACCORDANCE WITH THE MUTCD. SURROUNDING BUILDINGS WILL REMAIN IN OPERATION AND ACCESSIBLE DURING THE ENTIRE CONSTRUCTION PERIOD. THE CONTRACTOR SHALL CONDUCT OPERATIONS SO AS TO CAUSE THE LEAST POSSIBLE INTERFERENCE WITH NORMAL OPERATIONS AND ALLOW ACCESS TO PARKING LOTS TO THE MAXIMUM EXTENT POSSIBLE. CONTRACTOR SHALL COORDINATE TRAFFIC CONTROL WITH BASE PWD (431-8361), AREAS UPON COMPLETION OF CONSTRUCTION.
7. SEEDING SHALL BE DONE IMMEDIATELY AFTER CONSTRUCTION OF TRASH DE-WATERING OF THE STREAM SECTION UNDER CONSTRUCTION IS REQUIRED FOR ALL CONCRETE WORK.

DEMOLITION NOTES:


1. CONTRACTOR SHALL DEMOLISH 2000 SF OF EXISTING ASPHALT ROADWAY AT LOCATION SHOWN ON ASSOCIATED SITE PLAN.
2. CONTRACTOR SHALL REMOVE APPROX. 56 LF OF EXISTING 72" CORRUGATED METAL PIPE FROM STREAM BED.
3. REMOVE EXISTING RIP-RAP AS NECESSARY TO FACILITATE CONSTRUCTION OF 2 NEW CONCRETE HEADWALLS.
4. ALL CONSTRUCTION TRASH AND DEBRIS MUST BE HAULED OFF BASE.

REPAIR NOTES:

1. CONTRACTOR SHALL INSTALL 56 LINEAR FEET OF NEW 72" RCP IN PLACE OF OLD 72" CORRUGATED METAL PIPE. PLEASE SEE SHEET C11 FOR ASSOCIATED DETAILS. FINAL INVERTS OF PIPE MUST BE 1' BELOW ELEVATION OF STREAM BED. ALL PIPE JOINTS SHALL BE SEALED, TAPERED, AND WRAPPED IN A LAYER OF SILT FENCE.
2. CONTRACTOR SHALL INSTALL NEW CONCRETE HEADWALLS ON UPSTREAM AND DOWNSTREAM ENDS OF NEW CULVERT PIPES IN ACCORDANCE WITH NDOT DETAILS. HEADWALLS SHALL BE STABILIZED WITH RIP-RAP AND GEOTEXTILE. SLOPES SHALL BE NO STEEPER THAN 3:1.
3. ALL BACKFILL SHALL BE COMPACTED IN 6" LIFTS TO DENSITY EQUAL TO AT LEAST 95% OF THAT BY COMPACTING SAMPLE OF MATERIAL IN ACCORDANCE WITH AASHTO 199.
4. ROAD MUST BE BACKFILLED BACK TO EXISTING ROADWAY ELEVATION OR PROVIDE MINIMUM 24" OF COVER OVER NEW RCP WHICH EVER IS GREATER.
5. ALL WORK MUST COMPLY WITH LATEST NDOT STANDARDS.

LEGEND

---	NEW	EXISTING	NEW
—E—	STREAM		
—GS—	ELECTRIC		
—ST—	GRAVITY SEWER	▲	STORM SEWER FLARED END SECTION
—WS—	STORM SEWER	○	STORM SEWER HEADWALL
—W—	WATER SERVICE	⋈	FIRE HYDRANT
—RW—	RAW WATER MAIN	⊕	UTILITY POLE
—FP—	PEDESTRIAN TRAIL	⊗	COMM MANHOLE
—FO—	FIRE PROTECTION	⊙	SEWER MANHOLE
—T—	FIBER OPTIC	⊛	WATER VALVE BOX
—S—	TELEPHONE	☀	EXTERIOR LIGHTING POINT
—S—	STEAM	—SF—	SILT FENCE
—Y—	SLIT FENCE	⊠	COMM RISER POINT
—RM—	FORCE MAIN	⊡	ELECTRICAL RISER POINT
—UF—	UNDERGROUND ELECTRIC	⊞	SEWER CLEANOUT
▨	AREA TO BE DEMOLISHED REPAVED	⊞	STORM SEWER INLET

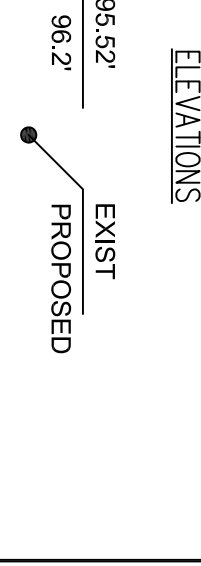

AMMENDMENT C-10

DEPARTMENT OF THE NAVY NAVAL FACILITIES ENGINEERING COMMAND
MARINE CORPS BASE
CAMP LEWINE, NORTH CAROLINA

C17-0052
TANK TRAIL AND CULVERT
REPAIRS BASEWIDE
DESIGN DIR. T. BURTON, P.E.
DATE: 6/7/17

DES: THOMAS BRADSHAW P.E.
DR: THOMAS BRADSHAW P.E.
CHK: DAVID TOWER P.E.
SUBMITTED BY: THOMAS BRADSHAW
DESIGN DIR.: T. BURTON, P.E.
DATE: 6/7/17
SIZE CODE: IDENT NO.
F 80091
CONST. CONTR. NO: 440085-17-B-0052
SCALE: AS SHOWN
SPEC: 05-17-0052
SHEET 11 OF 10

DISCLOSURE OF INFORMATION
CONTRACTOR SHALL COMPLY AS FOLLOWS:




- (A) THE CONTRACTOR SHALL NOT RELEASE TO ANYONE OUTSIDE THE CONTRACTOR'S ORGANIZATION ANY UNCLASSIFIED INFORMATION, REGARDLESS OF MEDIUM (E.G., FILM, TAPE, DOCUMENT), PERTAINING TO ANY PART OF THIS CONTRACT OR ANY PROGRAM RELATED TO THIS CONTRACT, UNLESS—
 - (1) THE CONTRACTING OFFICER HAS GIVEN PRIOR WRITTEN APPROVAL; OR
 - (2) THE INFORMATION IS OTHERWISE IN THE PUBLIC DOMAIN BEFORE THE DATE OF RELEASE.
- (B) REQUESTS FOR APPROVAL SHALL IDENTIFY THE SPECIFIC INFORMATION TO BE RELEASED, THE MEDIUM TO BE USED, AND THE PURPOSE FOR THE RELEASE. THE CONTRACTOR SHALL SUBMIT ITS REQUEST TO THE CONTRACTING OFFICER AT LEAST 45 DAYS BEFORE THE PROPOSED DATE FOR RELEASE.
- (C) THE CONTRACTOR AGREES TO INCLUDE A SIMILAR REQUIREMENT IN EACH SUBCONTRACT UNDER THIS CONTRACT. SUBCONTRACTORS SHALL SUBMIT REQUESTS FOR AUTHORIZATION TO RELEASE THROUGH THE PRIME CONTRACTOR TO THE CONTRACTING OFFICER.

DISCLOSURE OF INFORMATION
CONTRACTOR SHALL COMPLY AS FOLLOWS:

- (A) THE CONTRACTOR SHALL NOT RELEASE TO ANYONE OUTSIDE THE CONTRACTOR'S ORGANIZATION ANY UNCLASSIFIED INFORMATION, REGARDLESS OF MEDIUM (E.G., FILM, TAPE, DOCUMENT), PERTAINING TO ANY PART OF THIS CONTRACT OR ANY PROGRAM RELATED TO THIS CONTRACT, UNLESS—
 - (1) THE CONTRACTING OFFICER HAS GIVEN PRIOR WRITTEN APPROVAL; OR
 - (2) THE INFORMATION IS OTHERWISE IN THE PUBLIC DOMAIN BEFORE THE DATE OF RELEASE.
- (B) REQUESTS FOR APPROVAL SHALL IDENTIFY THE SPECIFIC INFORMATION TO BE RELEASED, THE MEDIUM TO BE USED, AND THE PURPOSE FOR THE RELEASE. THE CONTRACTOR SHALL SUBMIT ITS REQUEST TO THE CONTRACTING OFFICER AT LEAST 45 DAYS BEFORE THE PROPOSED DATE FOR RELEASE.
- (C) THE CONTRACTOR AGREES TO INCLUDE A SIMILAR REQUIREMENT IN EACH SUBCONTRACT UNDER THIS CONTRACT. SUBCONTRACTORS SHALL SUBMIT REQUESTS FOR AUTHORIZATION TO RELEASE THROUGH THE PRIME CONTRACTOR TO THE CONTRACTING OFFICER.

SEEDING SCHEDULE

VEGETATIVE SEEDING
 AFTER COMPLETION OF GRADING ACTIVITIES AND THE
 CONSTRUCTION OF SWALES, ALL EXPOSED AREAS SHALL
 PERMANENTLY SODDED TO
 THE FOLLOWING SPECIFICATIONS:
 PERMANENT VEGETATION (JANUARY THROUGH DECEMBER)
 CENTIPEDE SOD SHALL BE INSTALLED AT ALL DISTURBED AREAS
 UPON COMPLETION OF WORK.

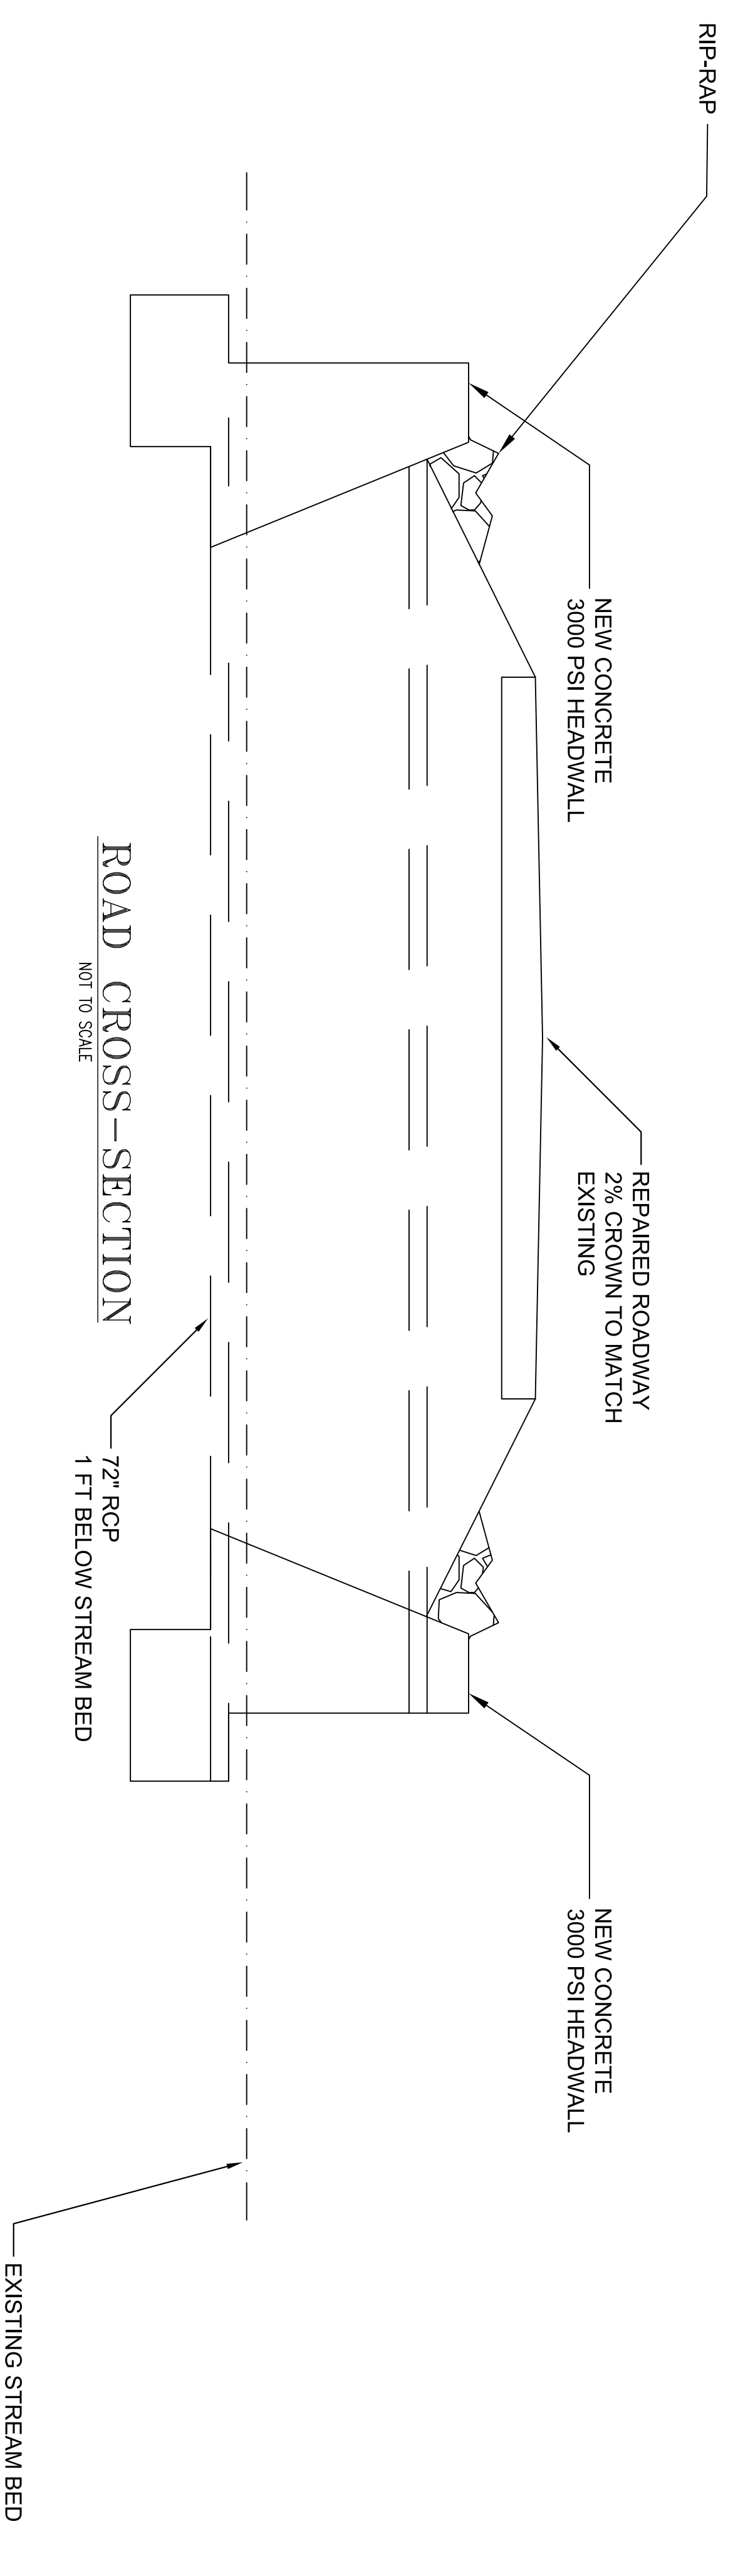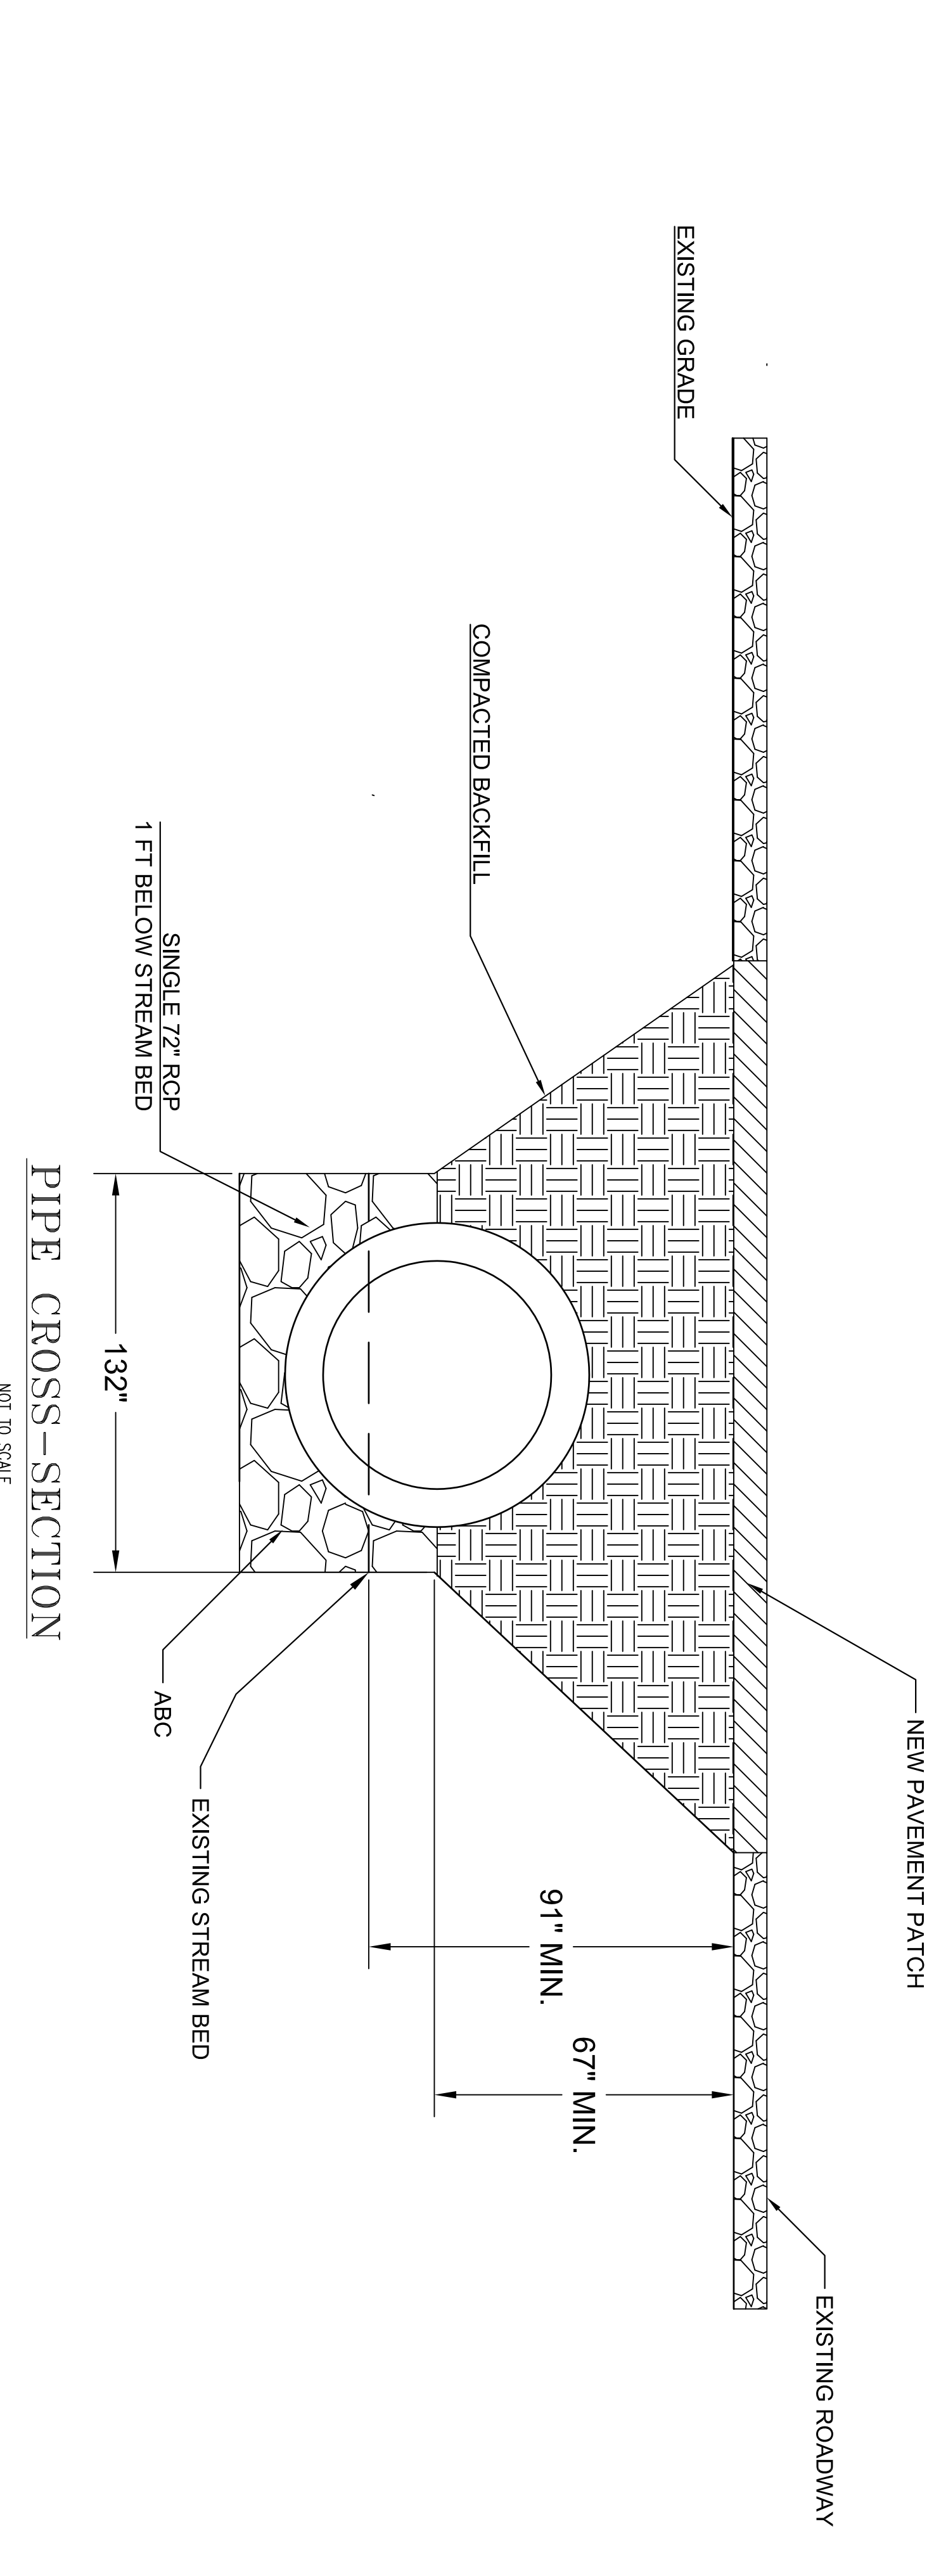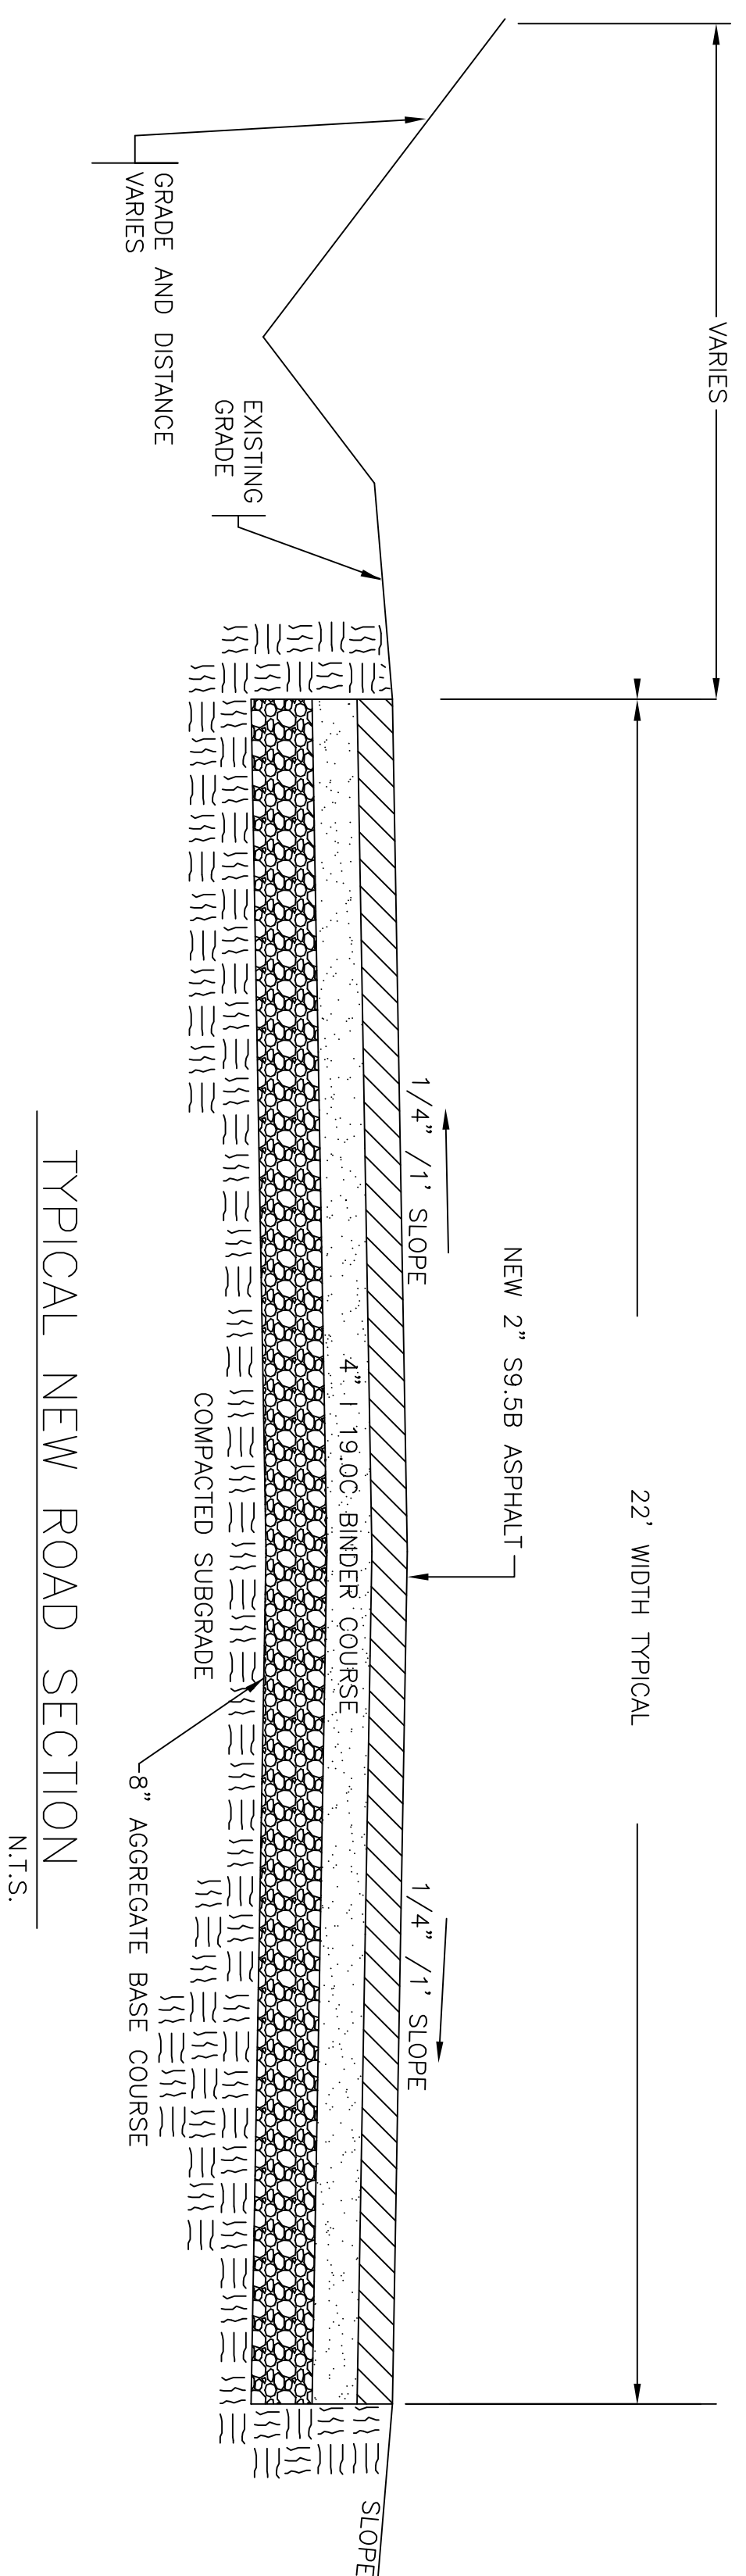

AMMENDMENT

C-11

DEPARTMENT OF THE NAVY
 NAVAL FACILITIES ENGINEERING COMMAND
 MARINE CORPS BASE
 CAMP LEJUNE, NORTH CAROLINA

C17-0052

TANK TRAIL AND CULVERT
 REPAIRS BASEWIDE

LEWIS CREEK RD DETAILS

FWD DRAWING NO.
 6001XXXX

CONST. CONTR. NO. 40005-17-B-0052
 SCALE: AS SHOWN SPEC. 05-17-0052 SHEET 12 OF 10

DISCLOSURE OF INFORMATION

CONTRACTOR SHALL COMPLY AS FOLLOWS:

(A) THE CONTRACTOR SHALL NOT RELEASE TO ANYONE OUTSIDE THE CONTRACTOR'S ORGANIZATION ANY UNCLASSIFIED INFORMATION, REGARDLESS OF MEDIUM (E.G., FILE, TAP, DOCUMENT), PERTAINING TO ANY PART OF THIS CONTRACT OR ANY PROGRAM RELATED TO THIS CONTRACT UNLESS—

(1) THE CONTRACTING OFFICER HAS GIVEN PRIOR WRITTEN APPROVAL; OR
 (2) THE INFORMATION IS OTHERWISE IN THE PUBLIC DOMAIN BEFORE THE DATE OF RELEASE.

(B) REQUESTS FOR APPROVAL SHALL IDENTIFY THE SPECIFIC INFORMATION TO BE RELEASED, THE MEDIUM TO BE USED, AND THE PURPOSE FOR THE RELEASE. THE CONTRACTOR SHALL SUBMIT THIS REQUEST TO THE CONTRACTING OFFICER AT LEAST 45 DAYS BEFORE THE PROPOSED DATE FOR RELEASE.

(C) THE CONTRACTOR AGREES TO INCLUDE A SIMILAR REQUIREMENT IN EACH SUBCONTRACT UNDER THIS CONTRACT. SUBCONTRACTORS SHALL SUBMIT REQUESTS FOR AUTHORIZATION TO RELEASE THROUGH THE PRIME CONTRACTOR TO THE CONTRACTING OFFICER.